


PROJECT MANAGER Curtis Holloway (540)374-3367
 SURVEYED BY, DATE John Sehn, L.S. (540) 899-4464, 11/05/2019
 DESIGN BY Minwoo Ho, P.E. (540)899-4044
 SUBSURFACE UTILITY BY, DATE Accurmark, Inc., 08/31/2015

| REVISED | STATE | STATE | | SHEET NO. |
|---------|-------|---------|--------------------------|-----------|
| | ROUTE | PROJECT | | |
| | VA. | 95 | 0095-016-637, R201, M501 | 2G |

OVERALL PROJECT LAYOUT

DESIGN FEATURES RELATING TO CONSTRUCTION OR TO REGULATION AND CONTROL OF TRAFFIC MAY BE SUBJECT TO CHANGE AS DEEMED NECESSARY BY THE DEPARTMENT

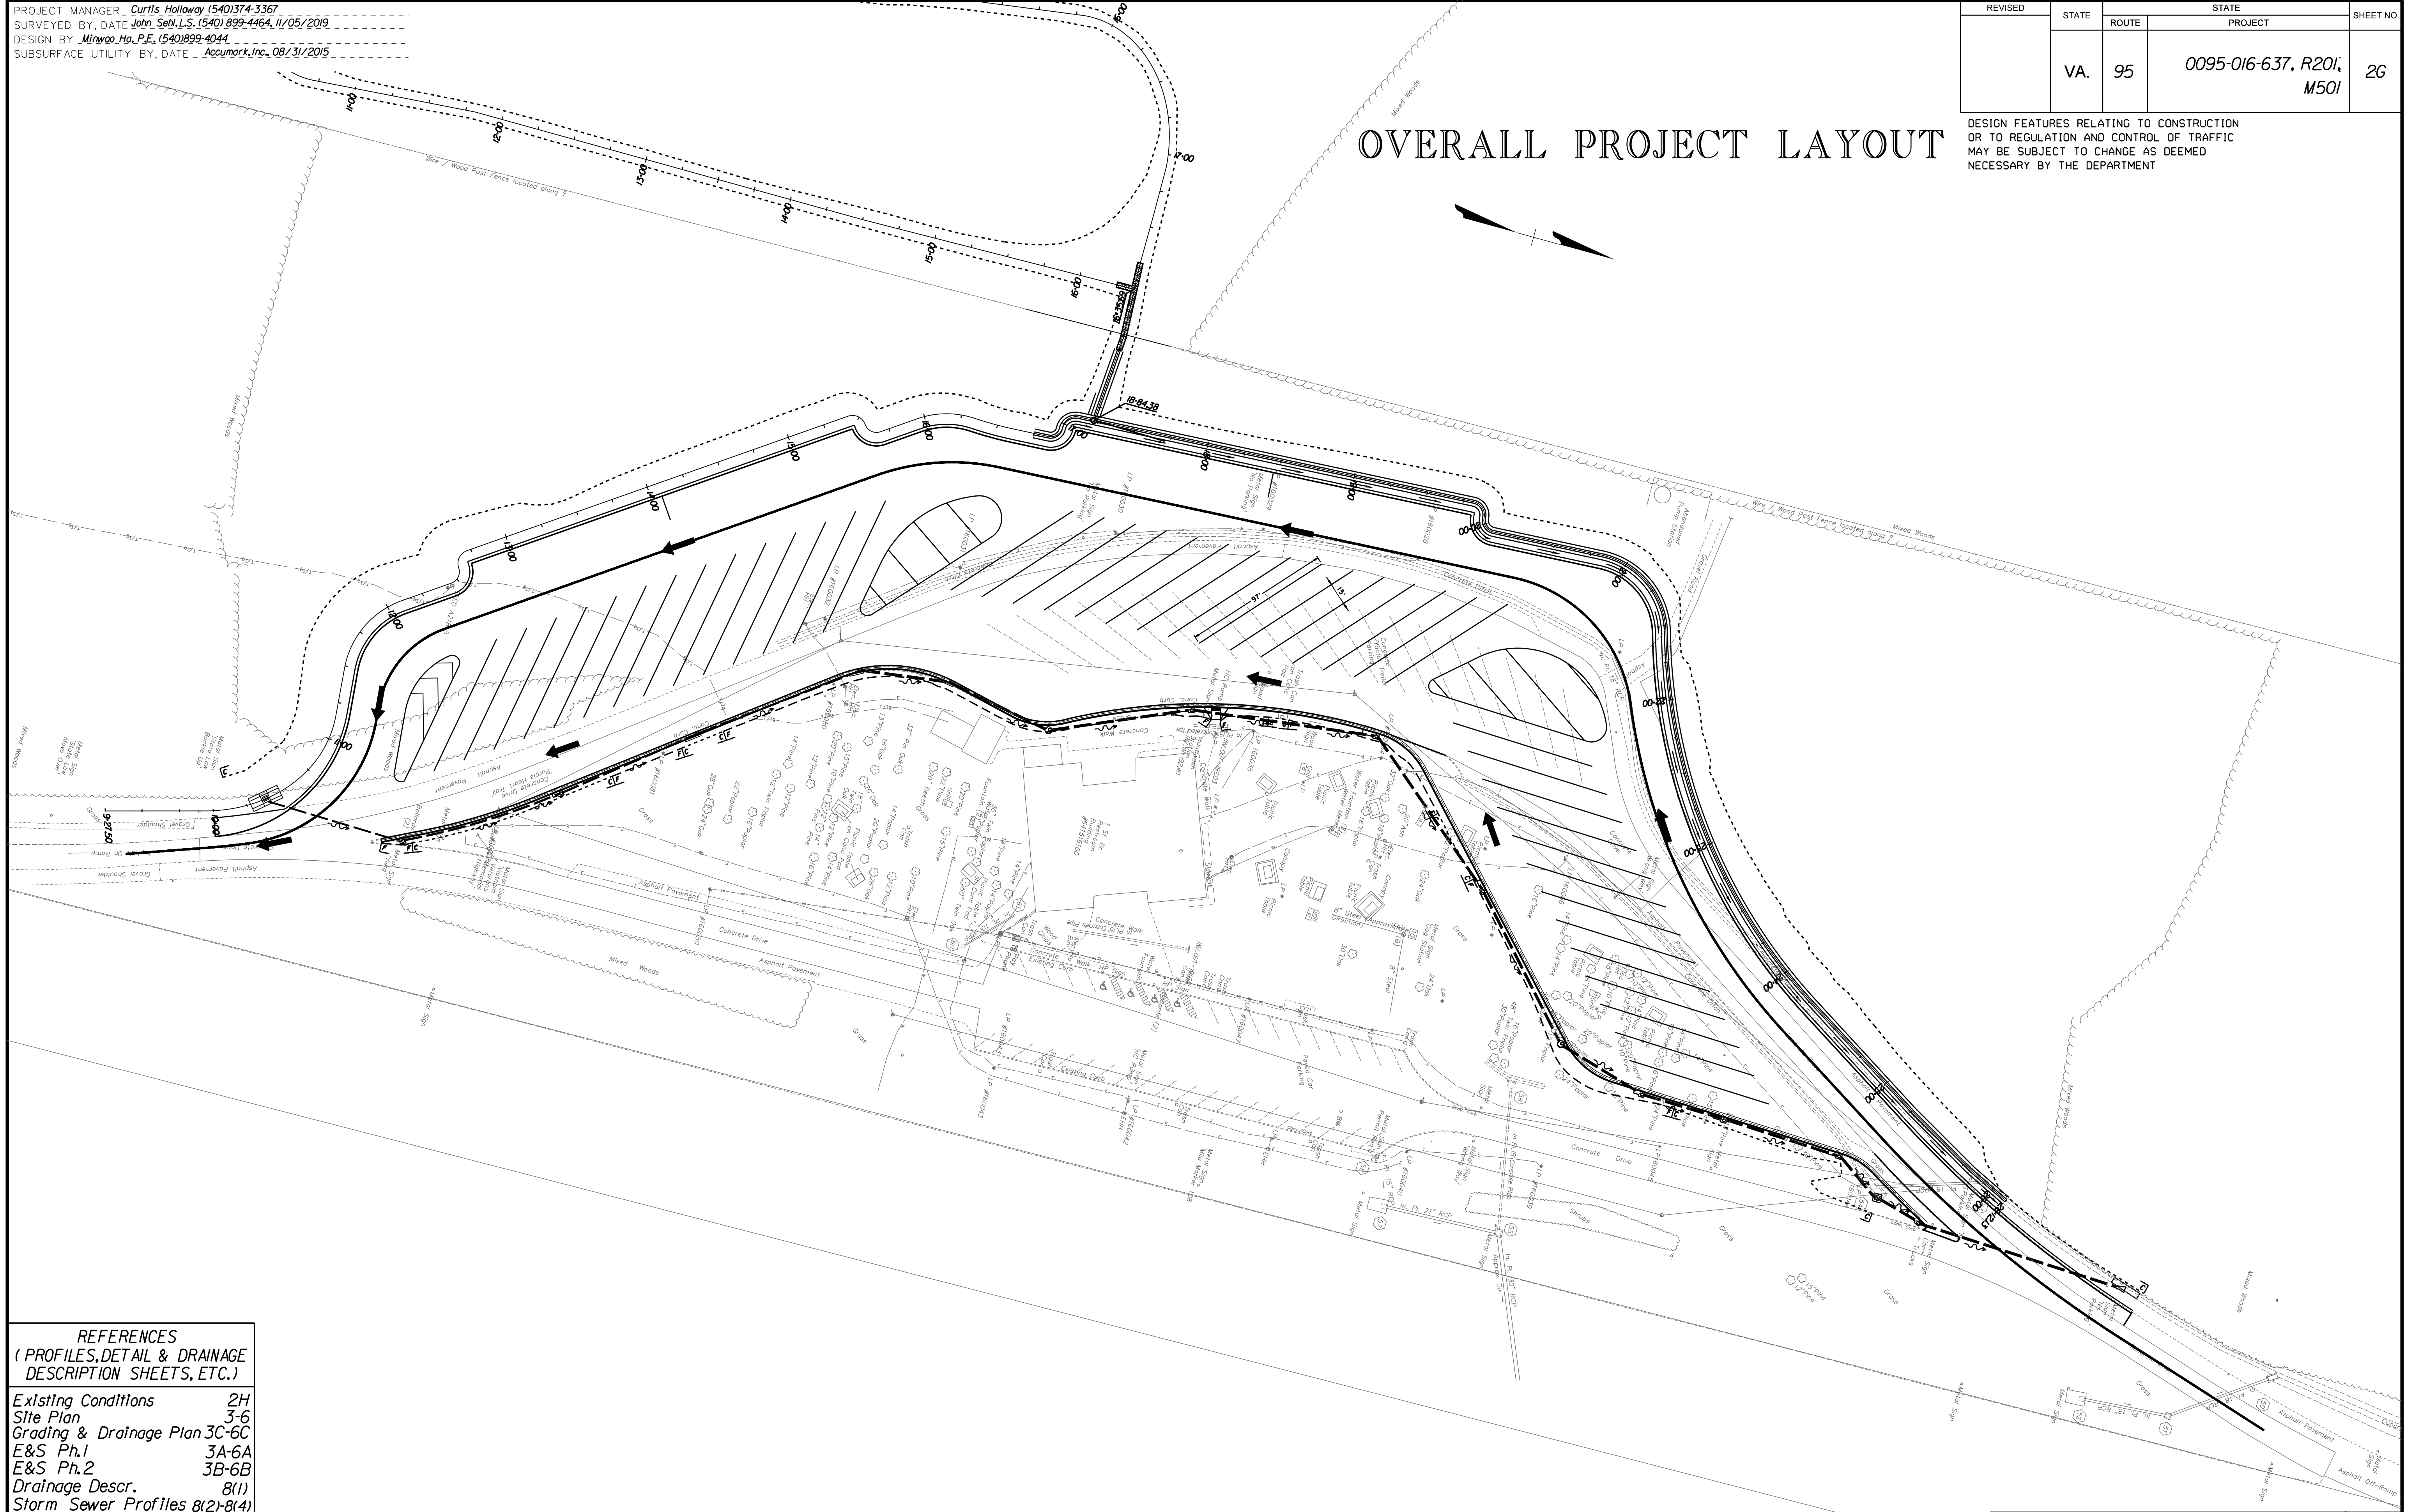

| REFERENCES (PROFILES, DETAIL & DRAINAGE DESCRIPTION SHEETS, ETC.) | |
|--|-----------|
| Existing Conditions | 2H |
| Site Plan | 3-6 |
| Grading & Drainage Plan | 3C-6C |
| E&S Ph.1 | 3A-6A |
| E&S Ph.2 | 3B-6B |
| Drainage Descr. | 8(1) |
| Storm Sewer Profiles | 8(2)-8(4) |
| Ditch Profiles | 8(5)-8(7) |

| | | |
|---------------------|-------------------------|-----------------|
| SCALE 0 50' 100' | PROJECT 0095-016-637 | SHEET NO. 2G |
|---------------------|-------------------------|-----------------|

FREDERICKSBURG DISTRICT DESIGN UNIT